

ARCHITECT

VLK Architects, Inc.
7915 F.M. 1960 West, Suite 214
Houston, Texas 77070
Main Phone: 281.871.2300
www.vlkarchitects.com

CLK Architects & Associates
615 N. Upper Broadway, Suite 1250
Corpus Christi, Texas 78401
Main Phone: 361.884.3295
www.clkarch.com

CIVIL ENGINEER


Urban Engineering
2725 Swarthier
Corpus Christi, Texas 78404
Main Phone: 361.854.3101
www.urbaneng.com

M.E.P. ENGINEER

DBR Engineering
8626 Tesoro Drive, Suite 702
San Antonio, Texas 78217
Main Phone: 210.546.0200
www.dbrinc.com

DRISCOLL I.S.D.
DRISCOLL, TX

Driscoll ISD Central Admin. & Gymnasium Building Renovation

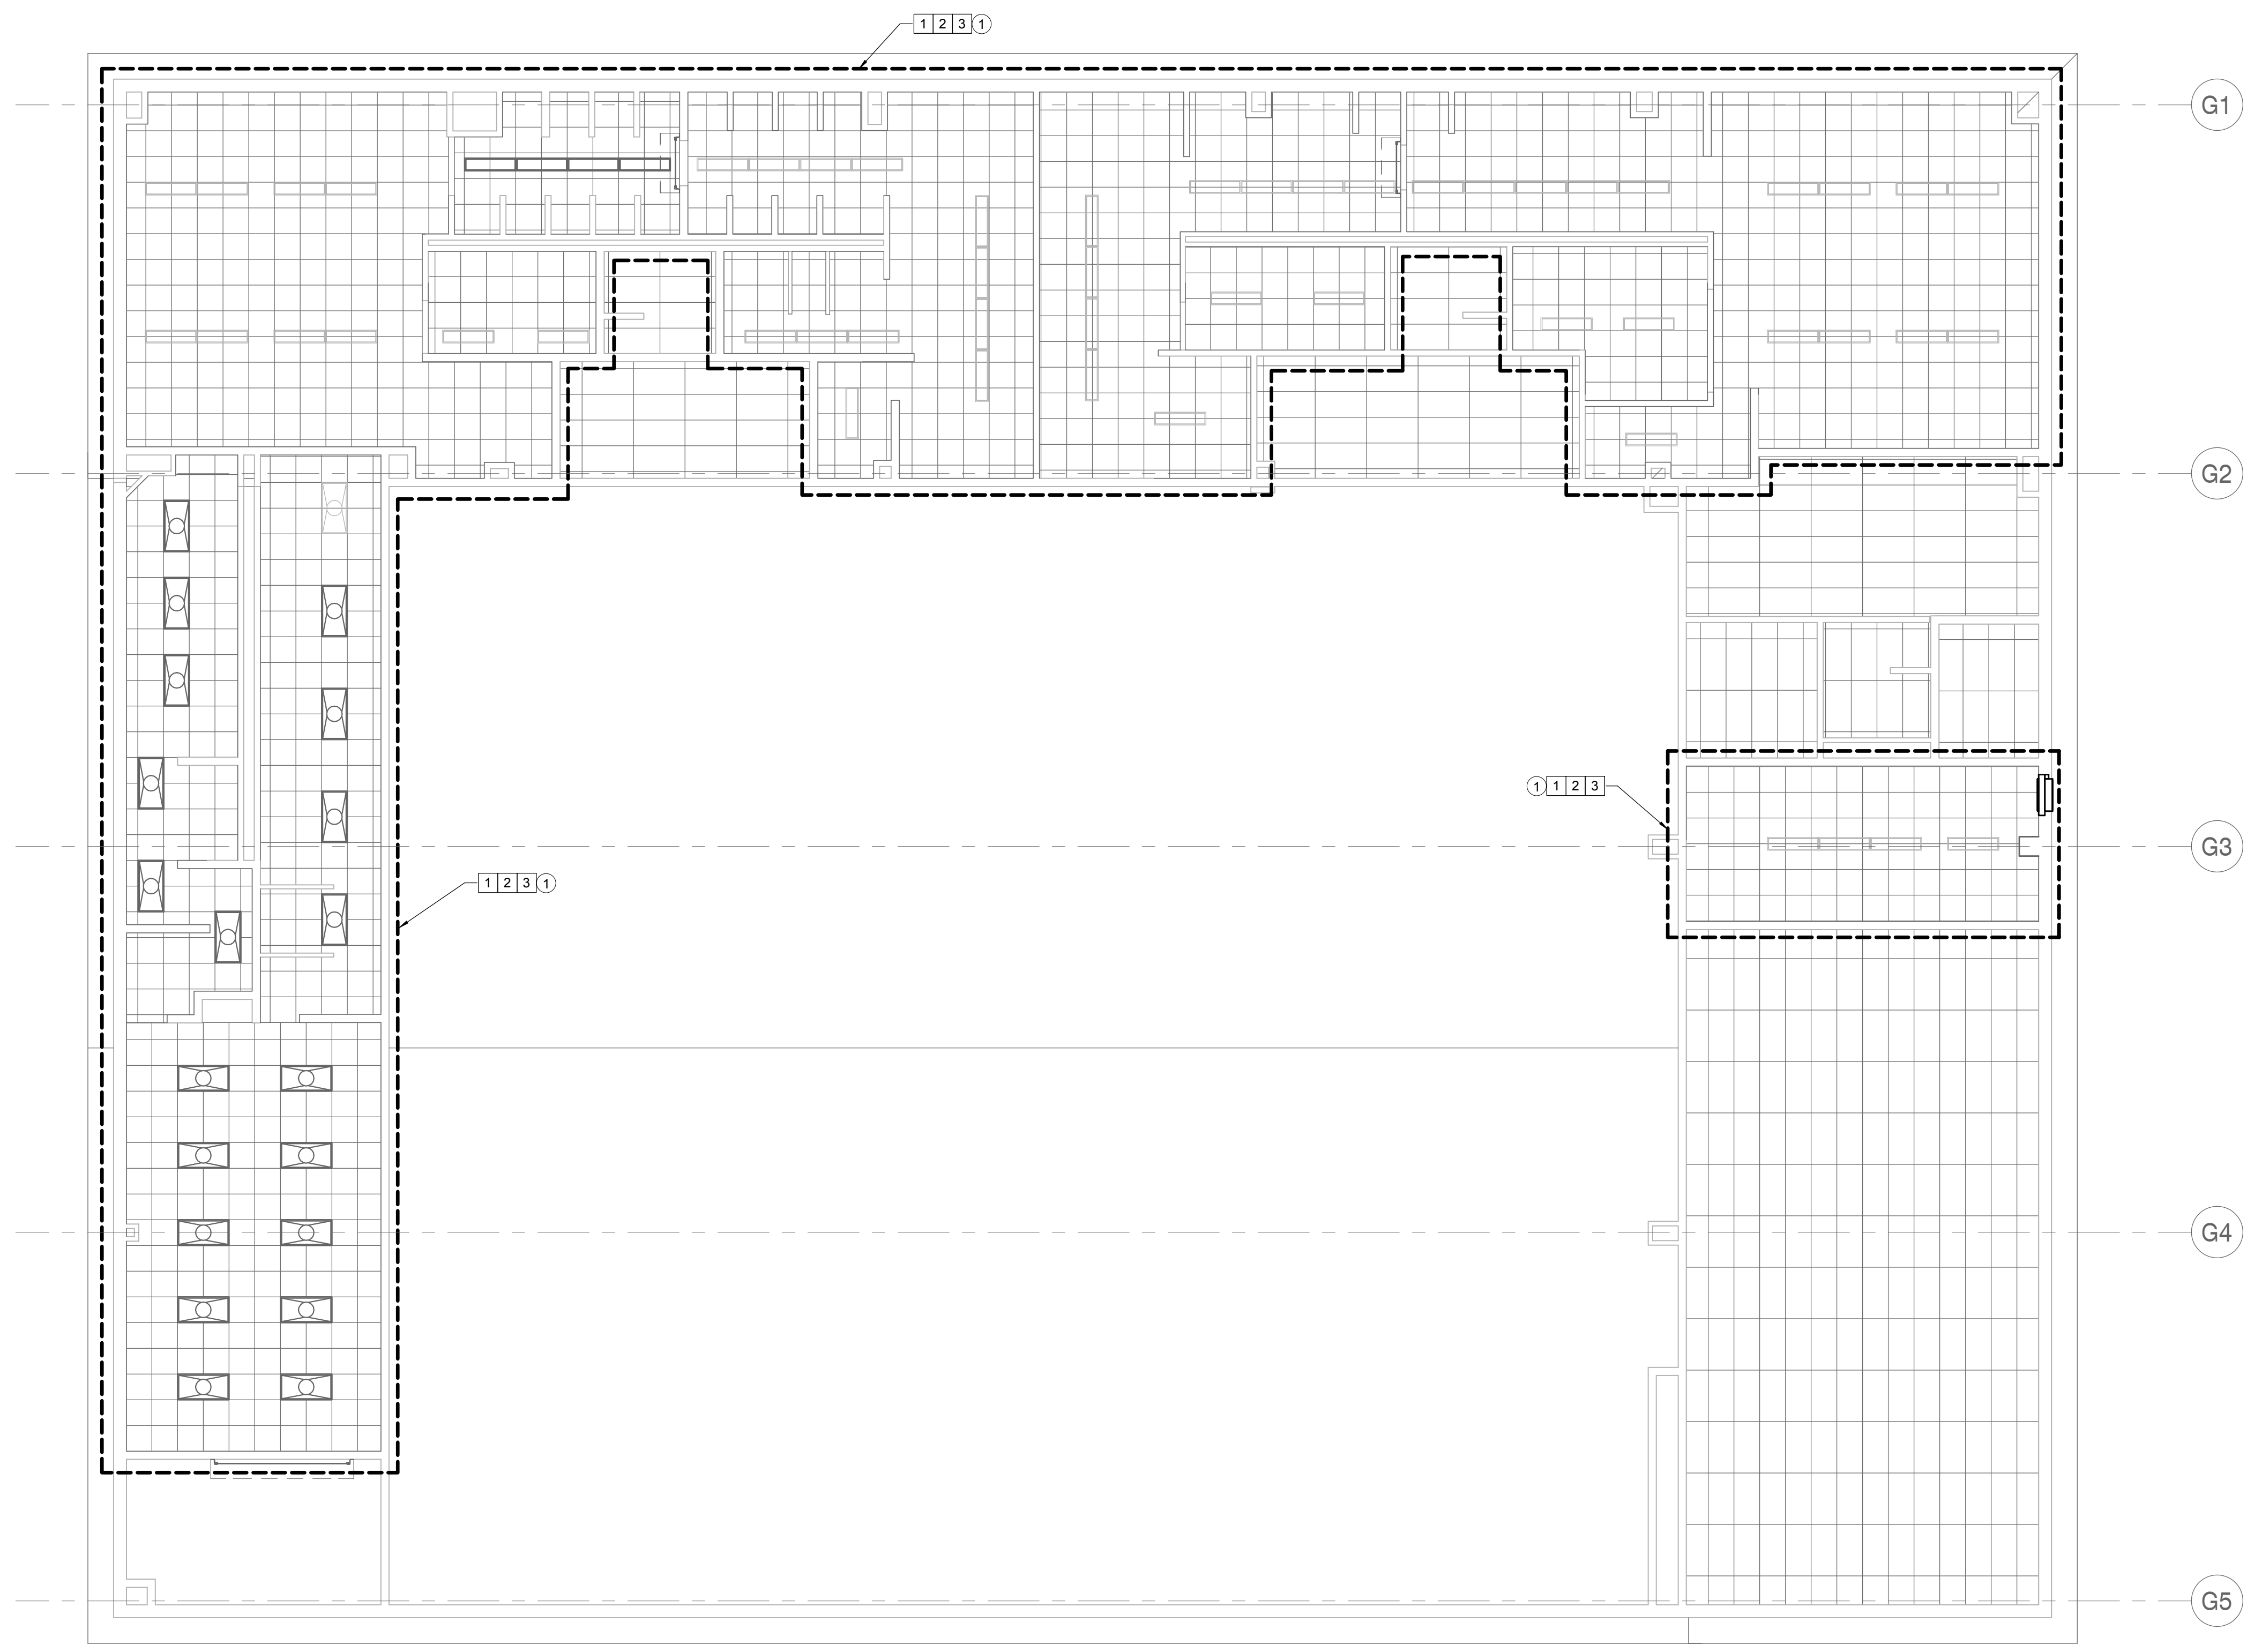

MECHANICAL GENERAL NOTES:

1. ALL EXISTING AIR DEVICES AND EQUIPMENT TO BE RELOCATED OR REUSED MUST BE CLEANED, PAINTED, AND ALL DAMAGED PARTS MUST BE REPAIRED OR REPLACED.

MECHANICAL KEYED NOTES:

- 1 REMOVE ALL EXISTING SUPPLY AIR DIFFUSERS IN THIS AREA AND TEMPORARILY SUSPEND FROM STRUCTURE. REINSTALL TO FIT WITHIN NEW CEILING GRID. FIELD VERIFY EXISTING QUANTITIES AND LOCATIONS.
- 2 REMOVE ALL EXISTING RETURN AIR GRILLES IN THIS AREA AND STORE TEMPORARILY. REINSTALL TO FIT WITHIN NEW CEILING GRID. FIELD VERIFY EXISTING QUANTITIES AND LOCATIONS.
- 3 REMOVE ALL EXISTING EXHAUST AIR GRILLES IN THIS AREA AND TEMPORARILY SUSPEND FROM STRUCTURE. REINSTALL TO FIT WITHIN NEW CEILING GRID. FIELD VERIFY EXISTING QUANTITIES AND LOCATIONS.

ELECTRICAL KEYED NOTES:

- 1 REMOVE EXISTING LIGHT FIXTURES IN THIS AREA. CLEAN AND RELAMP. REINSTALL TO FIT WITHIN NEW CEILING GRID. COORDINATE FINAL LOCATION WITH MECHANICAL AND PLUMBING IF NECESSARY.

1 MECHANICAL ELECTRICAL PLAN - GYMNASIUM BUILDING
ME2.04 1/8" = 1'-0"



03/21/2016

REVISIONS

Revision No.

Director	DBR
Approver	DBR
Designer	
Proj. Coord.	Quality Control
Checker	DBR

PROJECT NO.

1342.01

SHEET TITLE

MECHANICAL ELECTRICAL
GYMNASIUM PLAN

SHEET NO.

ME2.04



DBR Project Number 166025.000

ZM JC DA CF --