


UNIVERSITY OF TEXAS AT AUSTIN



PROJECT MANAGEMENT & CONSTRUCTION SERVICES
PROJECT SUPPORT
CAPITAL PROJECT NO. CP627448
REPLACE PUMP HOUSE 2
MARINE SCIENCE INSTITUTE (MSI)
FISHERIES & MARICULTURE LABS (FAML)
1300 PORT STREET
PORT ARANSAS, TX 78373



LOCATION MAP

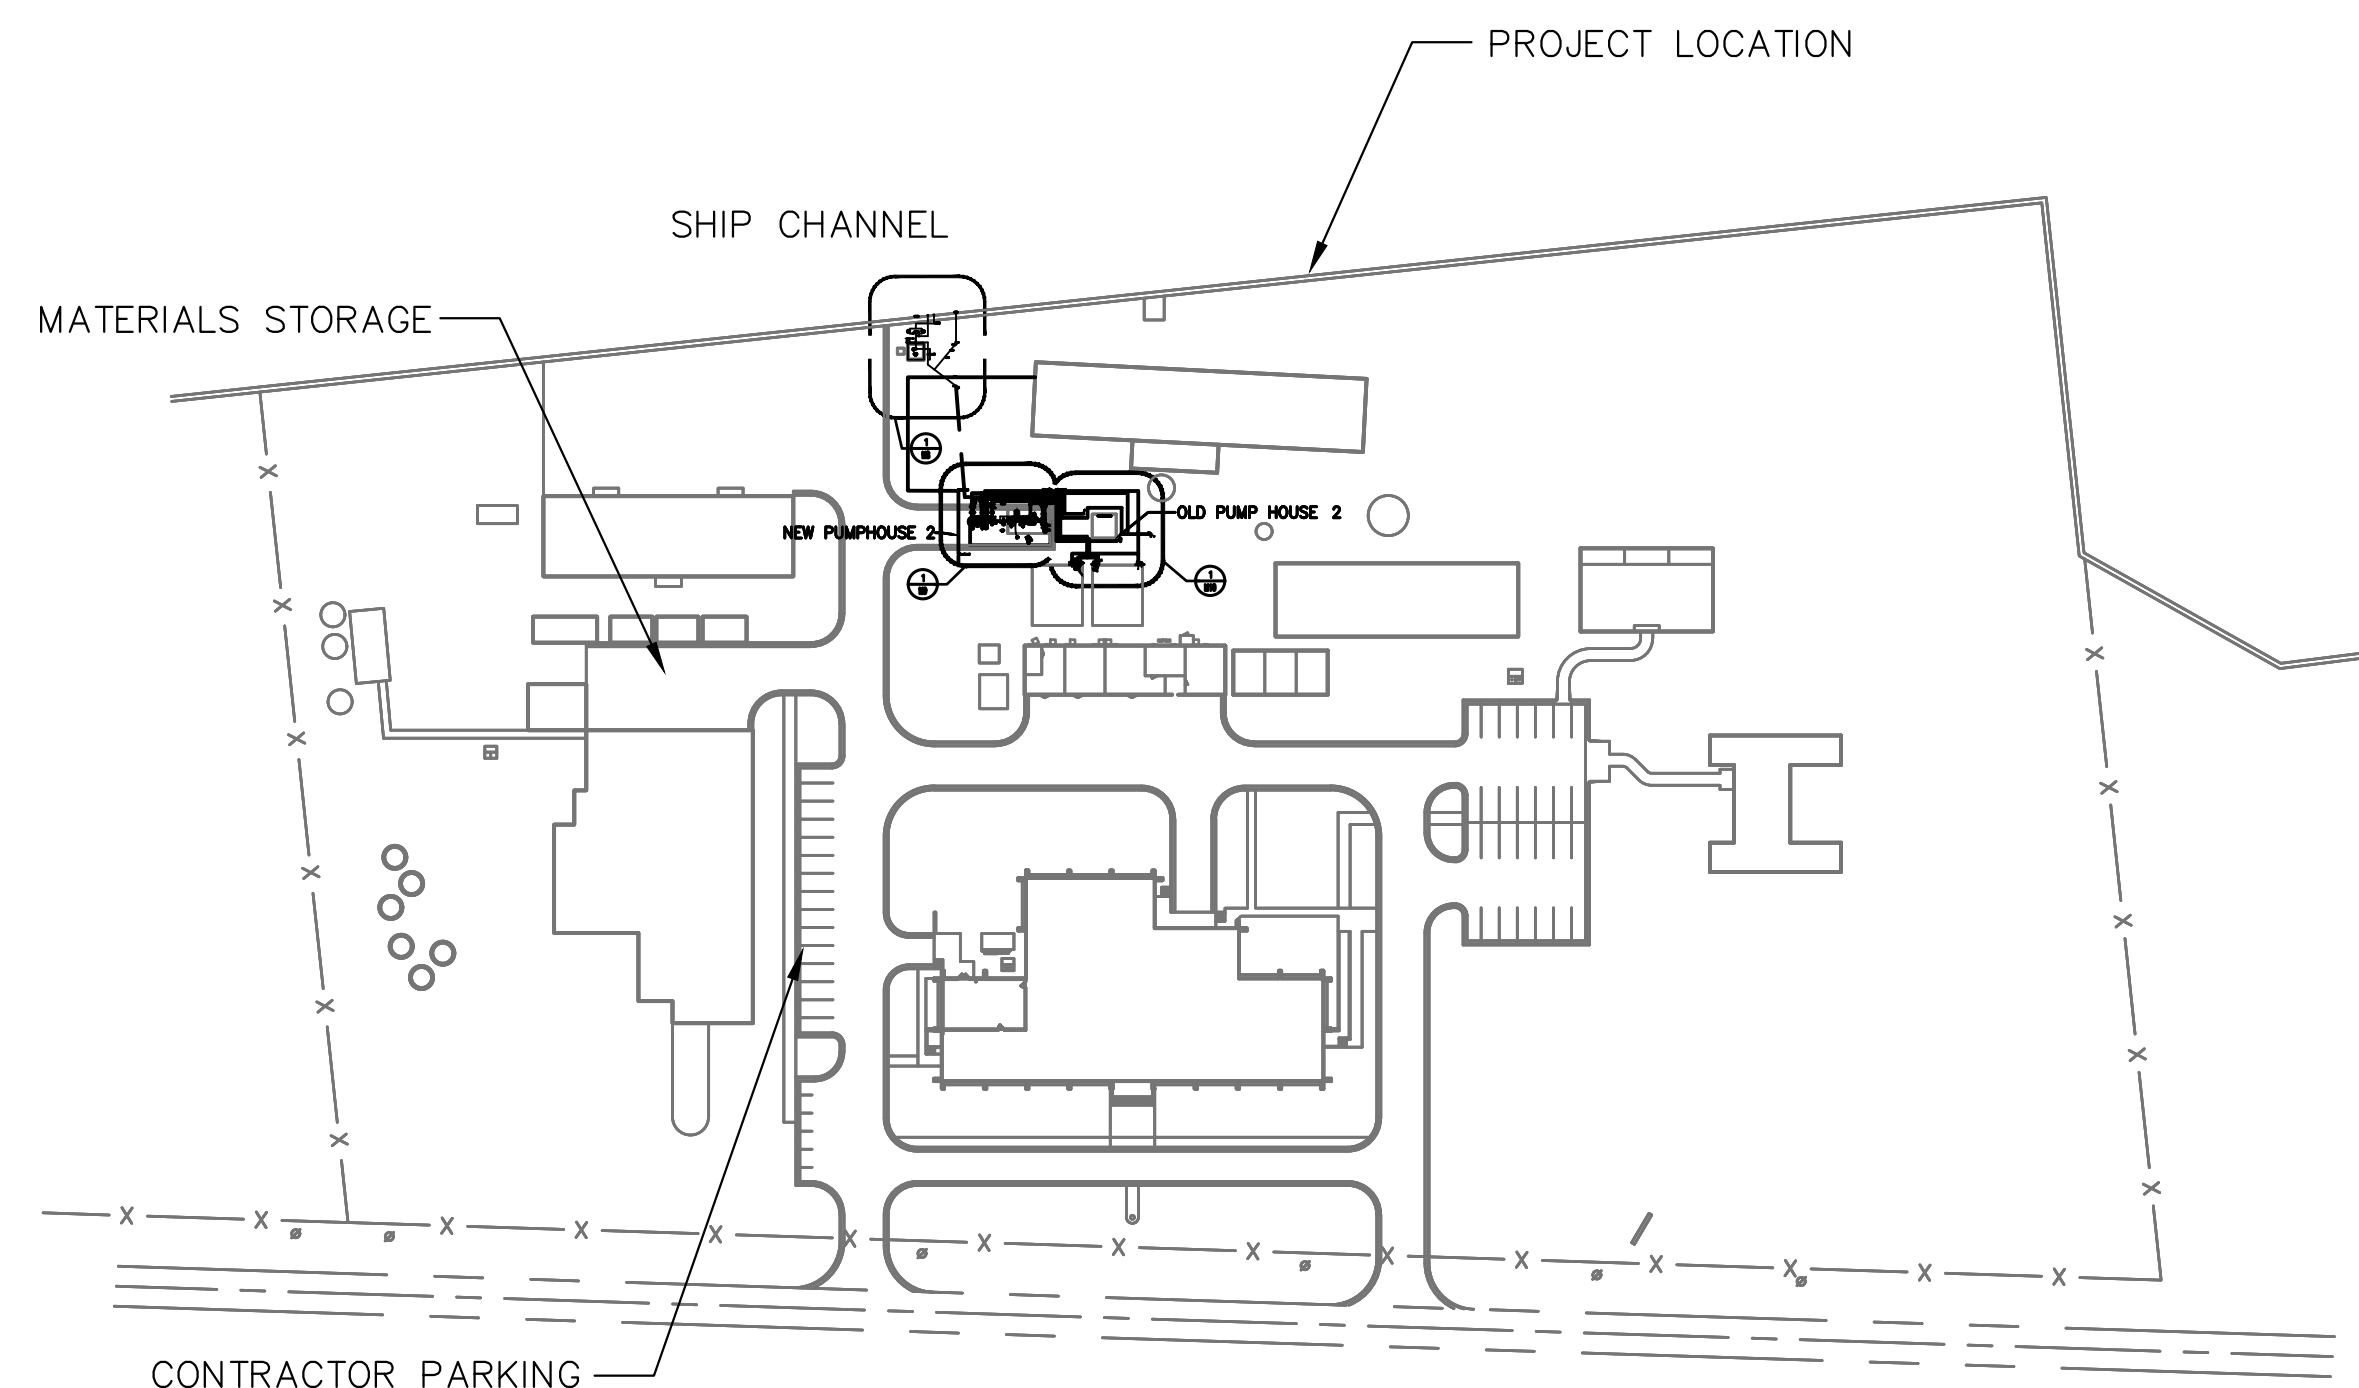

KEY PLAN

APPLICABLE CURRENT CODES FOR THIS BID PACKAGE
International Building Code 2015
International Mechanical Code 2015
International Plumbing Code 2015
National Electrical Code 2014
International Fire Code 2015
International Fire Gas Code 2015
International Energy Conservation Code 2015

2 working days
Call before you Dig.
CALL 811

COVER SHEET, LOCATOR MAP	CVR
ARCHITECTURAL GENERAL NOTES	AG-0.01
ARCHITECTURAL GENERAL NOTES	AG-0.02
ARCHITECTURAL SITE PLAN AND DETAILS	A-1.00
ARCHITECTURAL SITE PLAN AND DETAILS	A-1.01
FLOOR PLAN AND ELEVATIONS	A-2.01
SECTIONS AND DETAILS	A-3.01
SCHEDULES AND DETAILS	A-4.01
ELECTRICAL NOTES, SYMBOLS, & ABBREVIATIONS	E1
ELECTRICAL SPECIFICATIONS	E2
ELECTRICAL SITE PLAN - DEMOLITION	E3
ELECTRICAL SITE PLAN - NEW	E4
ELECTRICAL PUMP HOUSE 2 PLAN - NEW	E5
ELECTRICAL ONE-LINE DIAGRAM - DEMOLITION	E6
ELECTRICAL ONE-LINE DIAGRAM - NEW	E7
MECHANICAL NOTES, SYMBOLS, & ABBREVIATIONS	M1
MECHANICAL SPECIFICATIONS	M2
MECHANICAL SITE PLAN - DEMOLITION	M3
MECHANICAL SYSTEMS - EXISTING DEMOLITION	M4
MECHANICAL SYSTEMS - EXISTING DEMOLITION	M5
MECHANICAL SYSTEMS - EXISTING DEMOLITION	M6
MECHANICAL SITE PLAN - NEW	M7
MECHANICAL SYSTEMS - NEW	M8
MECHANICAL SYSTEMS - NEW	M9
MECHANICAL SYSTEMS - NEW	M10
MECHANICAL SCHEDULES	M11
MECHANICAL DETAILS	M12
STRUCTURAL GENERAL NOTES	S0.0
STRUCTURAL PLANS AND DETAILS	S1.0
STRUCTURAL DETAILS	S2.0



S. Kanetzky
Engineering, LLC.
5920 W. William Cannon
Bldg. 7, Suite 200
Austin Texas 78749
(512) 326-3380 TEL.
(512) 329-5774 FAX
www.skaneng.com
TEXAS REGISTRATION #2356
SKE PROJECT # 1650416

DATE: 4/26/2017
DRAWN BY: EE/GB
CHECKED BY: MCB/SLK
APPROVED BY: SLK

PROJECT TEAM	NAME	ROLE
ARCHITECT	XXX	XXX
STRUC. ENGR.	XXX	XXX
MECH. ENGR.	XXX	XXX
ELECT. ENGR.	XXX	XXX
PLUMB. ENGR.	XXX	XXX
MECH. DESIG.	XXX	XXX
PLUMB. DESIG.	XXX	XXX
CONSTR. INSP.	XXX	XXX
OTHER	XXX	XXX

REVISIONS	NO.	DATE	DESCRIPTION

COVER SHEET FOR
MARINE SCIENCE INSTITUTE (MSI)
FISHERIES & MARICULTURE LABS. (FAML)
PROJECT MANAGEMENT & CONSTRUCTION SERVICES
PROJECT SUPPORT

PROJECT MANAGER	DATE
CEDRIC BOLEY	
PHASE	
CLIENT APPROVAL	



SEAL:
THIS DRAWING IS RELEASED FOR THE PURPOSE OF INTERIM REVIEW UNDER THE AUTHORITY OF STEVE L. KANETZKY, P.E., TX #64696 ON 04/26/17. IT IS NOT TO BE USED FOR CONSTRUCTION PURPOSES.

PROJECT NUMBER:
CP627448

SHEET:
CVR